


**COPYRIGHT NOTICE**

ALL RIGHTS RESERVED. BOYATTPLANS.COM AND ITS CONTENTS ARE PROTECTED BY COPYRIGHT LAW. ANY FORM OF REPRODUCTION, DISTRIBUTION, OR PUBLIC PERFORMANCE OF THESE DRAWINGS WITHOUT THE WRITTEN PERMISSION OF BOYATTPLANS.COM IS PROHIBITED. THE PURCHASE OF A SET OF HOME PLANS FROM BOYATTPLANS.COM CONSTITUTES AN AGREEMENT TO ACCEPT THE TERMS AND CONDITIONS OF THIS AGREEMENT. BOYATTPLANS.COM DOES NOT WARRANT THE ACCURACY OR COMPLETENESS OF THESE DRAWINGS. THE USER ASSUMES ALL LIABILITY FOR ANY ERRORS, OMISSIONS, OR DAMAGES RESULTING FROM THE USE OF THESE DRAWINGS. BOYATTPLANS.COM SHALL NOT BE RESPONSIBLE FOR ANY DAMAGES, INCLUDING STRUCTURAL FAILURES, RESULTING FROM THE USE OF THESE DRAWINGS. THE USER SHALL BE RESPONSIBLE FOR OBTAINING ALL NECESSARY PERMITS AND APPROVALS FROM LOCAL BUILDING OFFICIALS. BOYATTPLANS.COM SHALL NOT BE RESPONSIBLE FOR ANY DAMAGES, INCLUDING STRUCTURAL FAILURES, RESULTING FROM THE USE OF THESE DRAWINGS. THE USER SHALL BE RESPONSIBLE FOR OBTAINING ALL NECESSARY PERMITS AND APPROVALS FROM LOCAL BUILDING OFFICIALS.


THESE PLANS MUST BE THOROUGHLY REVIEWED BY A LICENSED ARCHITECT, PROFESSIONAL ENGINEER, OR CERTIFIED RESIDENTIAL DESIGNER OR A PROFESSIONAL ARCHITECT IN THE GEOGRAPHICAL AREA IN WHICH THESE PLANS WILL BE USED.

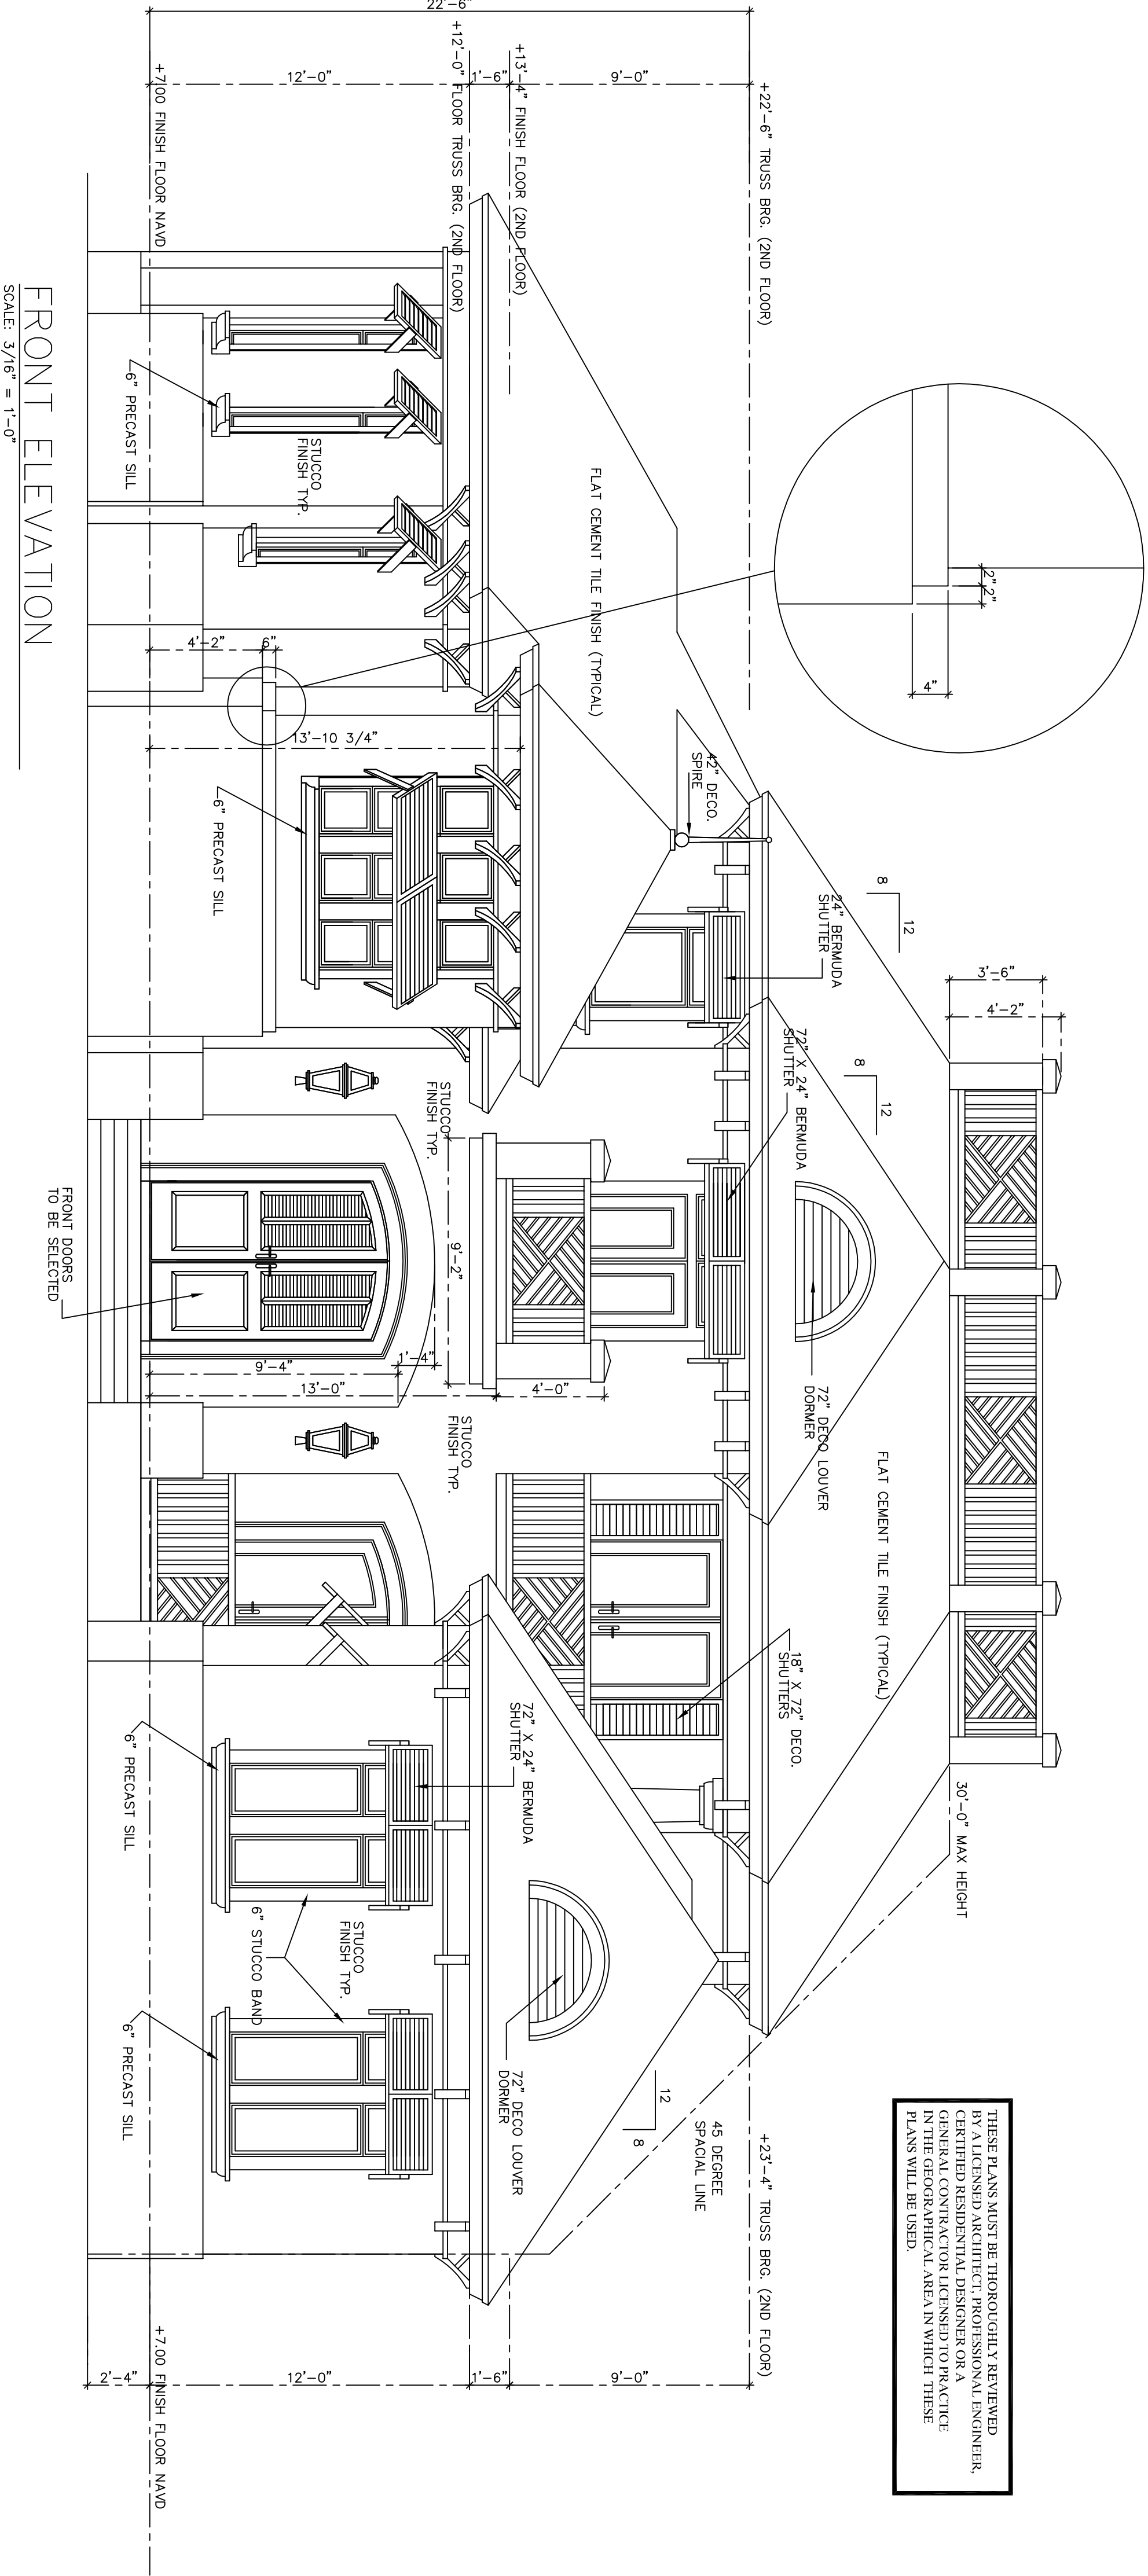

FRONT ELEVATION  
SCALE: 3/16" = 1'-0"

THESE PLANS ARE TO BE CONSIDERED AS CONCEPTUAL ARCHITECTURAL DRAWINGS ONLY AND SHALL NOT BE USED FOR CONSTRUCTION PURPOSES WITHOUT THE RESPONSIBILITY OF THE PURCHASER/OWNER. TO HAVE THE DRAWINGS REVIEWED BY AN ARCHITECT, CONTRACTOR, LICENSED TO PRACTICE IN THAT PARTICULAR GEOGRAPHICAL AREA, IN WHICH THESE PLANS ARE TO BE USED TO OBTAIN THE NECESSARY PERMITS AND APPROVALS FROM LOCAL BUILDING OFFICIALS TO INCLUDE FOUNDATION, FLOOR/ROOF TRUSS DESIGN, MECHANICAL, ELECTRICAL, ETC. REQUIRED FOR ACTUAL CONSTRUCTION AND DETERMINATION OF MATERIALS, MATERIAL COMPOSITION AND DETAILING OF MATERIALS DETERMINED BY THE PURCHASER/OWNER OR GENERAL CONTRACTOR AT THE TIME OF CONSTRUCTION.

THE OWNER AND/OR CONTRACTOR SHALL BE TOTALLY RESPONSIBLE FOR THE CONSTRUCTION PHASE OF THIS PROJECT AND SHALL BE RESPONSIBLE FOR OBTAINING ALL NECESSARY PERMITS AND APPROVALS FROM LOCAL BUILDING OFFICIALS (TO INCLUDE THE CEILING PLAN) AND THE EXTERIOR DESIGN. CERTAIN SECTIONS AND/OR DETAILS WHEN THE DRAWINGS ARE INCLUDED TO SHOW GENERAL CONSTRUCTION METHODS AND/OR TO EMPHASIZE CODE REQUIREMENTS, OR TO SHOW GENERAL ITEMS, BUT BY NO MEANS, REPRESENT ALL REQUIRED CONSTRUCTION FRAMEWORK, TECHNIQUES, OR DETAILING NECESSARY FOR THE STRUCTURAL COMPLETION OR WEATHERPROOFING OF THIS PROJECT. THE OWNER/CONTRACTOR SHALL ASSUME THE RESPONSIBILITY FOR ALL CONSTRUCTION ASSEMBLY PRACTICES AND METHODS, INCLUDING BUT NOT LIMITED TO THE FOLLOWING: FOUNDATION AND EXTERIOR WALL DESIGN, WATER PROOFING OF THE EXTERIOR WALLS, WINDOW/DOOR OPENINGS, AND ROOF, AND INTERIOR MATERIAL APPLICATIONS. THE ELECTRICAL PLAN (S) ARE INCLUDED HEREIN TO BE USED AS A GUIDE FOR PLACEMENT OF ELECTRICAL APPARATUS ONLY (I.E. LIGHT FIXTURES, SWITCHES, DETECTORS, OUTLETS, PANELS, ETC.) AND DO NOT NECESSARILY REFLECT A KNOWLEDGE OF THE REQUIRED CIRCUITRY, INSTALLATION PRACTICES OR ELECTRICAL CODE REQUIREMENTS. AS THE RESPONSIBILITY OF THE CONTRACTOR TO INSURE THE ELECTRICAL CODE REQUIREMENTS AND LISTING DESIGN MEETS ALL APPLICABLE CODES.

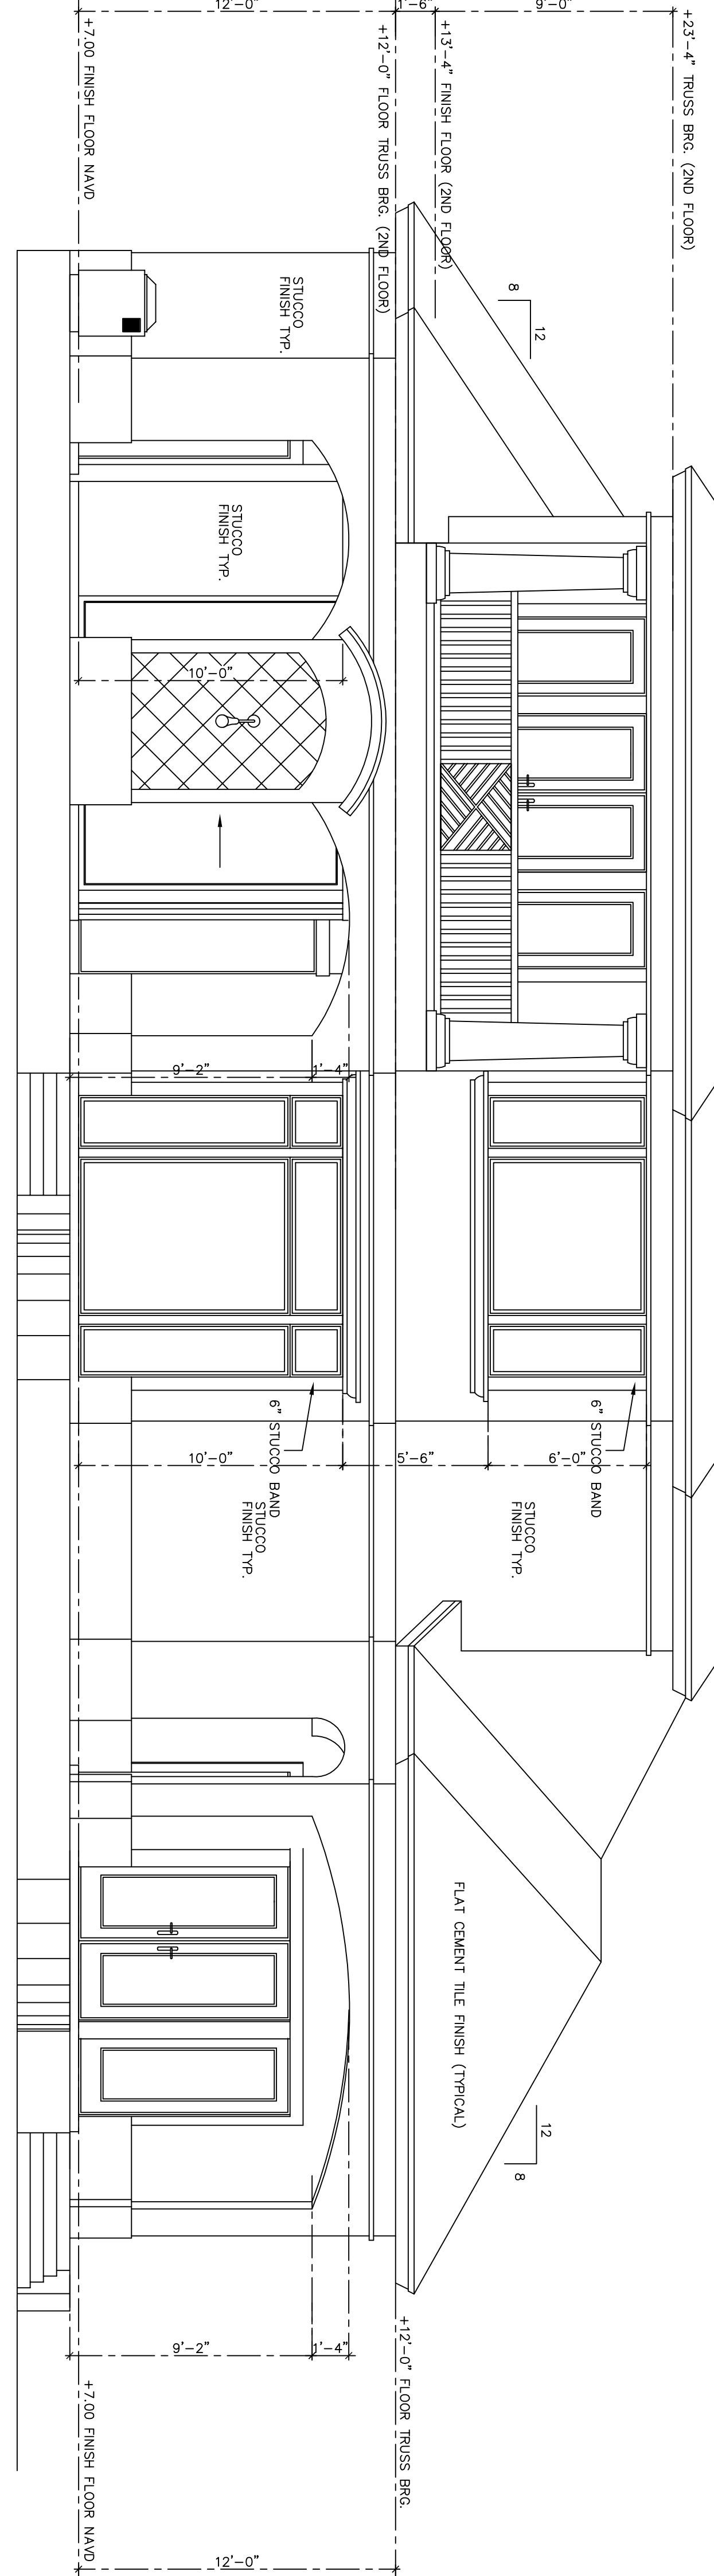

REAR ELEVATION  
SCALE: 3/16" = 1'-0"

ANY REPRODUCTION OF THESE PRINTS IS PROHIBITED BY FEDERAL COPYRIGHT LAWS. ANY ILLEGAL REPRODUCTION WILL BE AGGRESSIVELY PURSUED TO THE FULLEST EXTENT OF THE COPYRIGHT LAW.  
©THE BOYATT GALLERY OF HOMES

DESIGNER DISCLAIMER: BOYATTPLANS.COM has put substantial care and effort into this home design and the completion of these construction drawings. However, BOYATTPLANS.COM have not been contracted to provide personal consultation, site supervision or field inspection services and have no control over the construction materials, methods, or sequencing by the builder. For these reasons, as well as the gross variations in local building codes, Boyatt Gallery of Homes assumes no responsibility for any damages, including structural failures resulting from errors or omissions in these construction drawings. We strongly recommend that you, the homeowner, have these drawings thoroughly reviewed by a licensed architect, professional engineer, certified residential designer or general contractor licensed to practice in your area, in addition to your local building officials, prior to beginning construction.

DATE:	11/08/2011
PROJECT #:	BGH-3540
DRAWN BY:	TB
CHECKED BY:	
REVISIONS:	
SHEET #:	A-08

BOYATT DESIGN GROUP, INC. BOYATTPLANS.COM  
BOYATT DESIGN GROUP, INC. BOYATTPLANS.COM  
THESE PLANS ARE TO BE CONSIDERED AS CONCEPTUAL ARCHITECTURAL DRAWINGS ONLY AND SHALL NOT BE USED FOR CONSTRUCTION PURPOSES WITHOUT THE RESPONSIBILITY OF THE PURCHASER/OWNER. TO HAVE THE DRAWINGS REVIEWED BY AN ARCHITECT, CONTRACTOR, LICENSED TO PRACTICE IN THAT PARTICULAR GEOGRAPHICAL AREA, IN WHICH THESE PLANS ARE TO BE USED TO OBTAIN THE NECESSARY PERMITS AND APPROVALS FROM LOCAL BUILDING OFFICIALS TO INCLUDE FOUNDATION, FLOOR/ROOF TRUSS DESIGN, MECHANICAL, ELECTRICAL, ETC. REQUIRED FOR ACTUAL CONSTRUCTION AND DETERMINATION OF MATERIALS, MATERIAL COMPOSITION AND DETAILING OF MATERIALS DETERMINED BY THE PURCHASER/OWNER OR GENERAL CONTRACTOR AT THE TIME OF CONSTRUCTION.



**BOYATTPLANS.COM**  
931 EAST MAIN ST. SUITE B  
BLUE RIDGE, GEORGIA 30513  
Ph. 1-866-209-0247  
www.boyattplans.com

PLAN NAME:  
**BOCA GRAND**

PLAN NUMBER:  
**BGH-3540**